




FRONT SIDEWALL ELEVATION

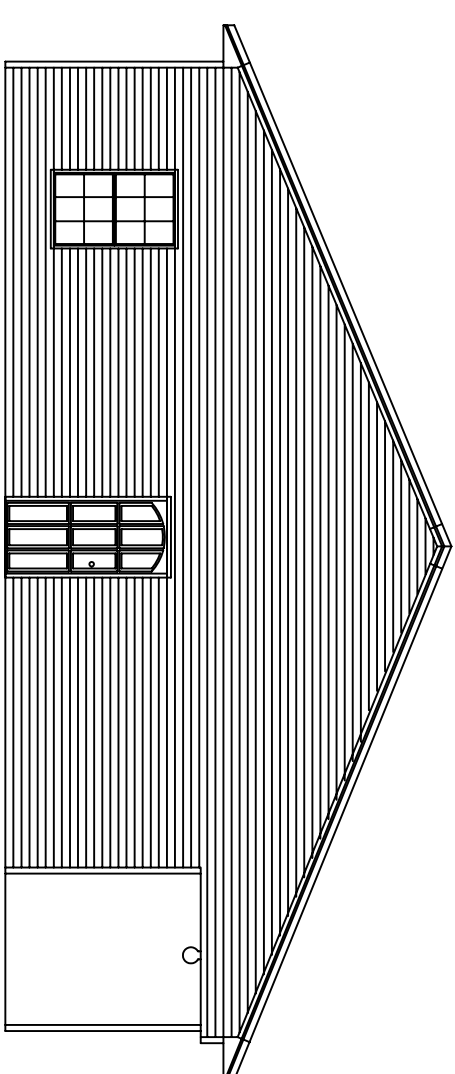

LEFT EDWALL ELEVATION

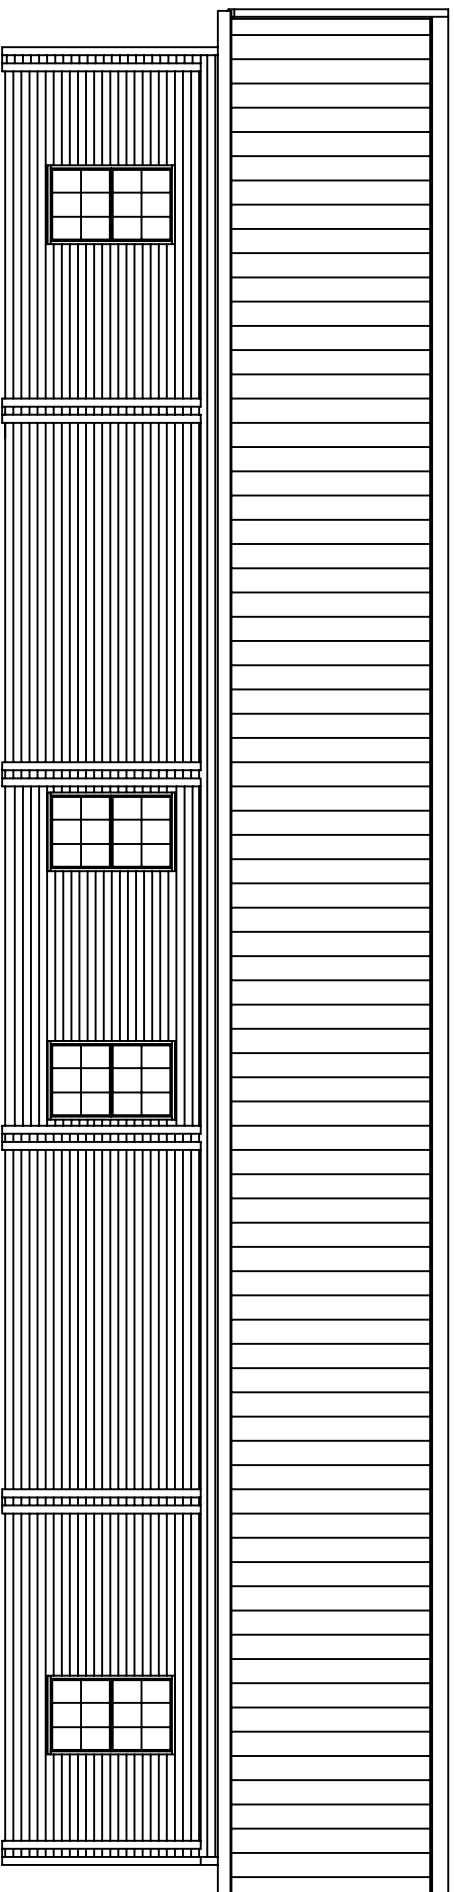

BACK SIDEWALL ELEVATION

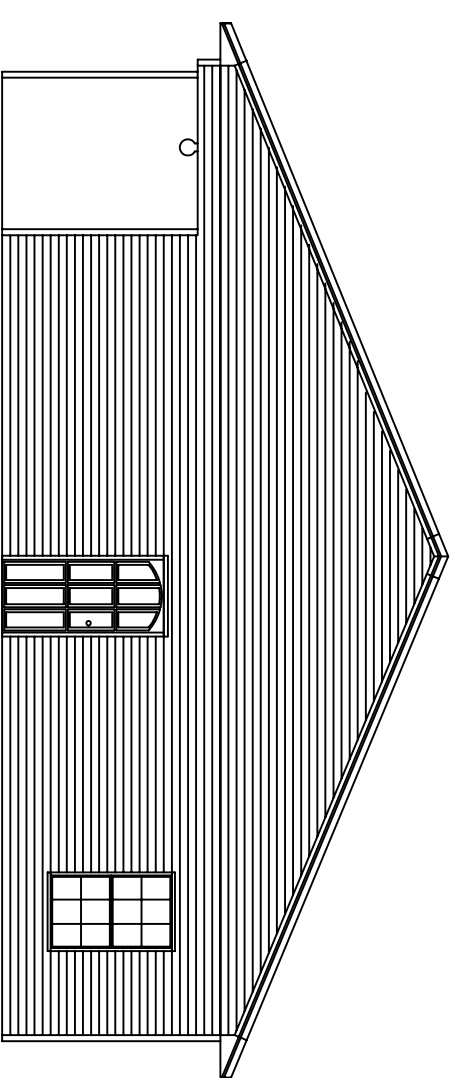

RIGHT ENDWALL ELEVATION




Kodiak Steel Homes, Inc
7301 Industry Drive
North Little Rock, AR 72117

Du-Plex
40' X 75'

FLOOR PLAN

DRAWING NO.


A1

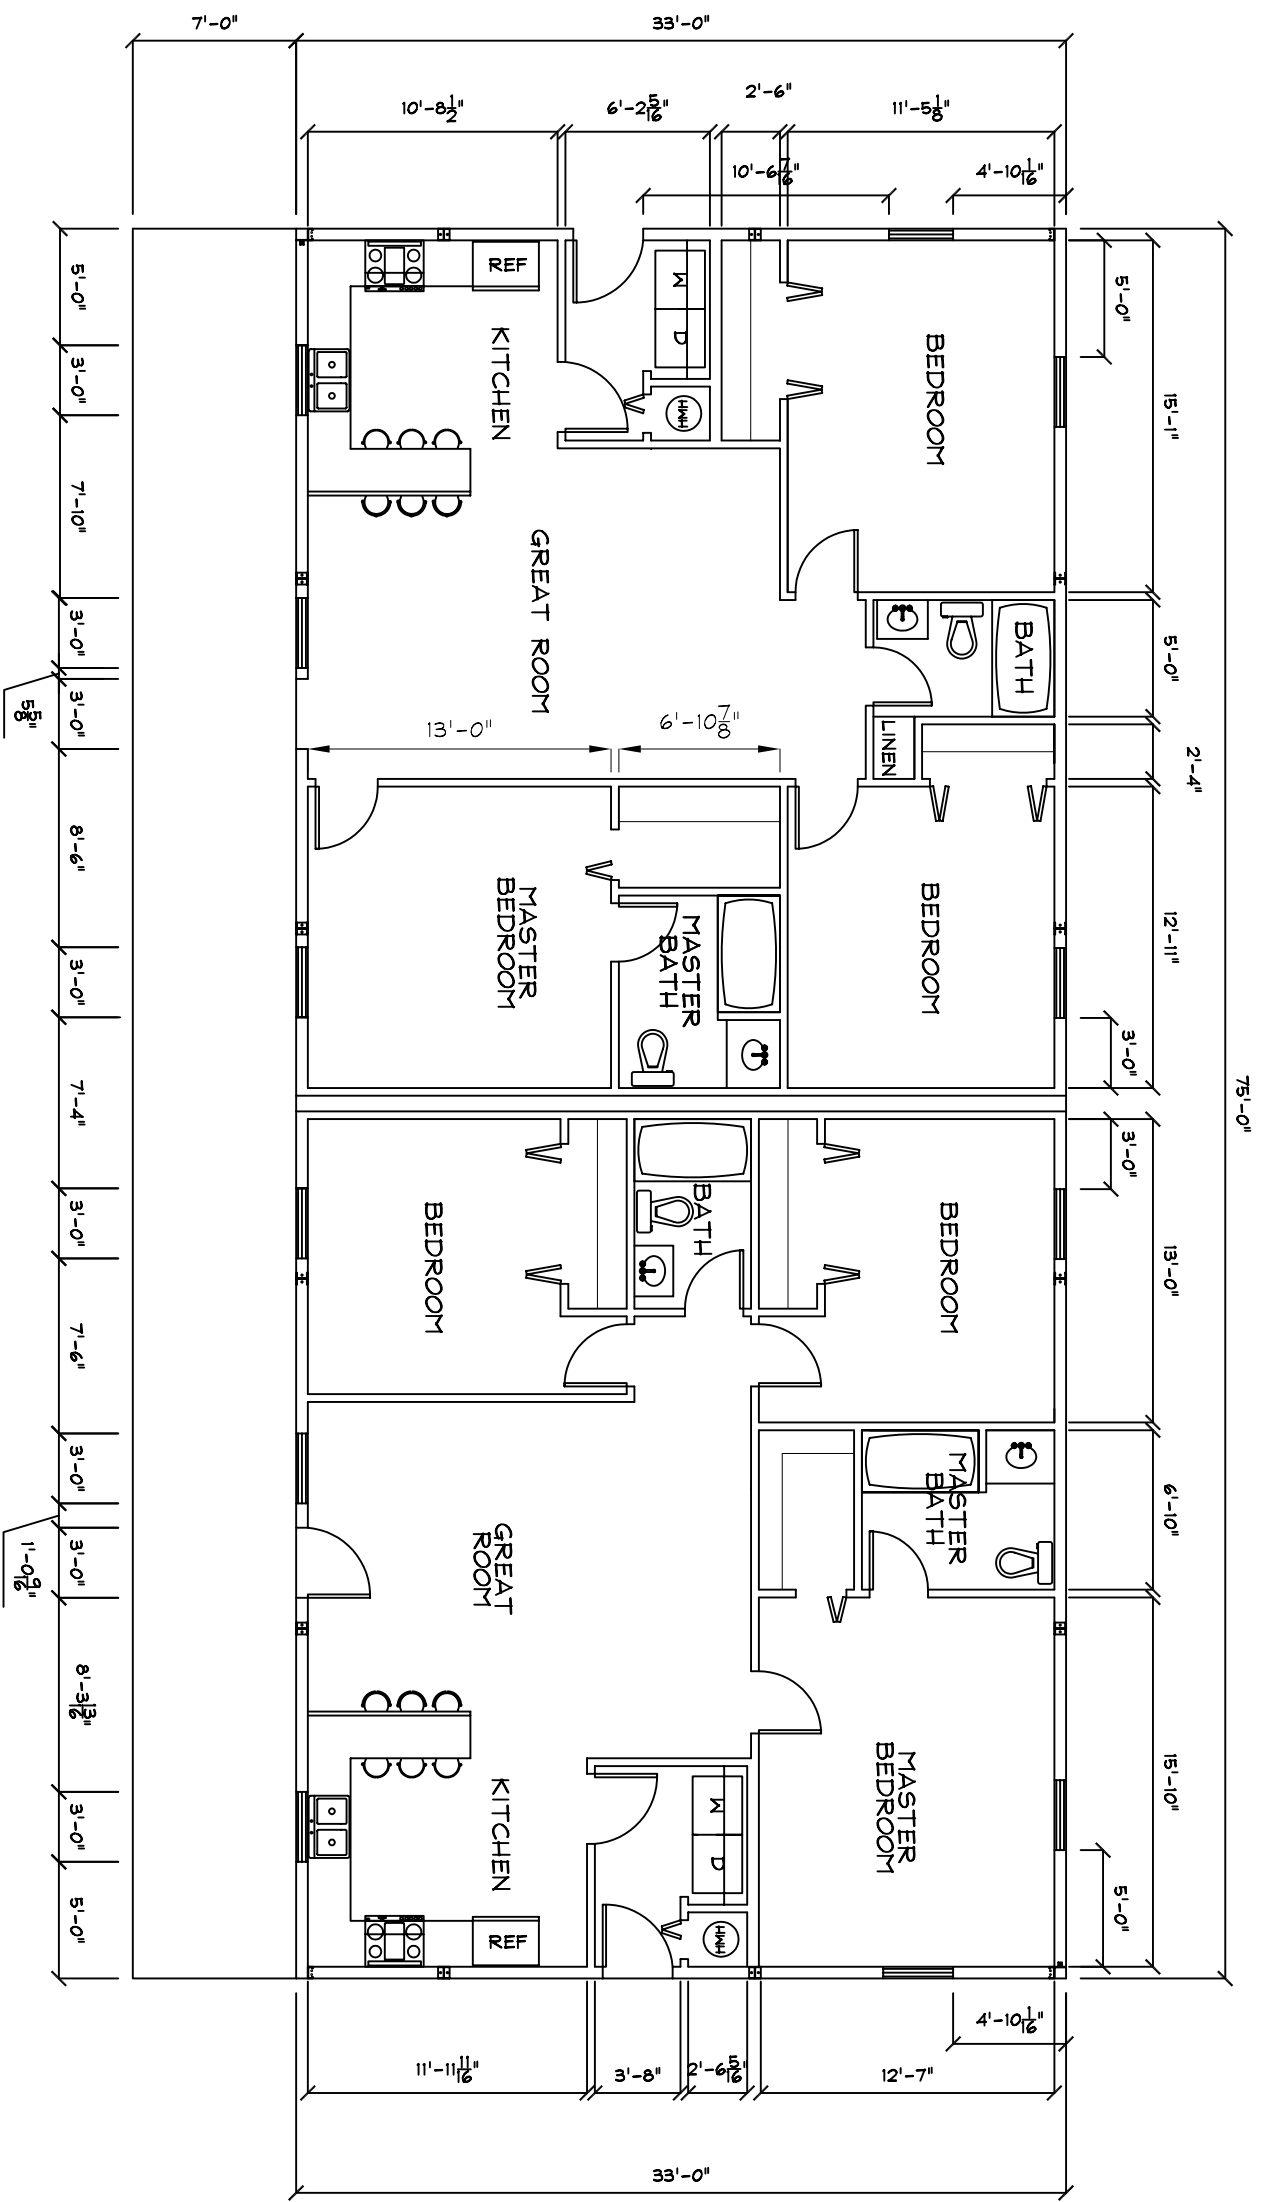




Kodiak Steel Homes, Inc
7301 Industry Drive
North Little Rock, AR 72117

DU-PLEX
40' X 75'

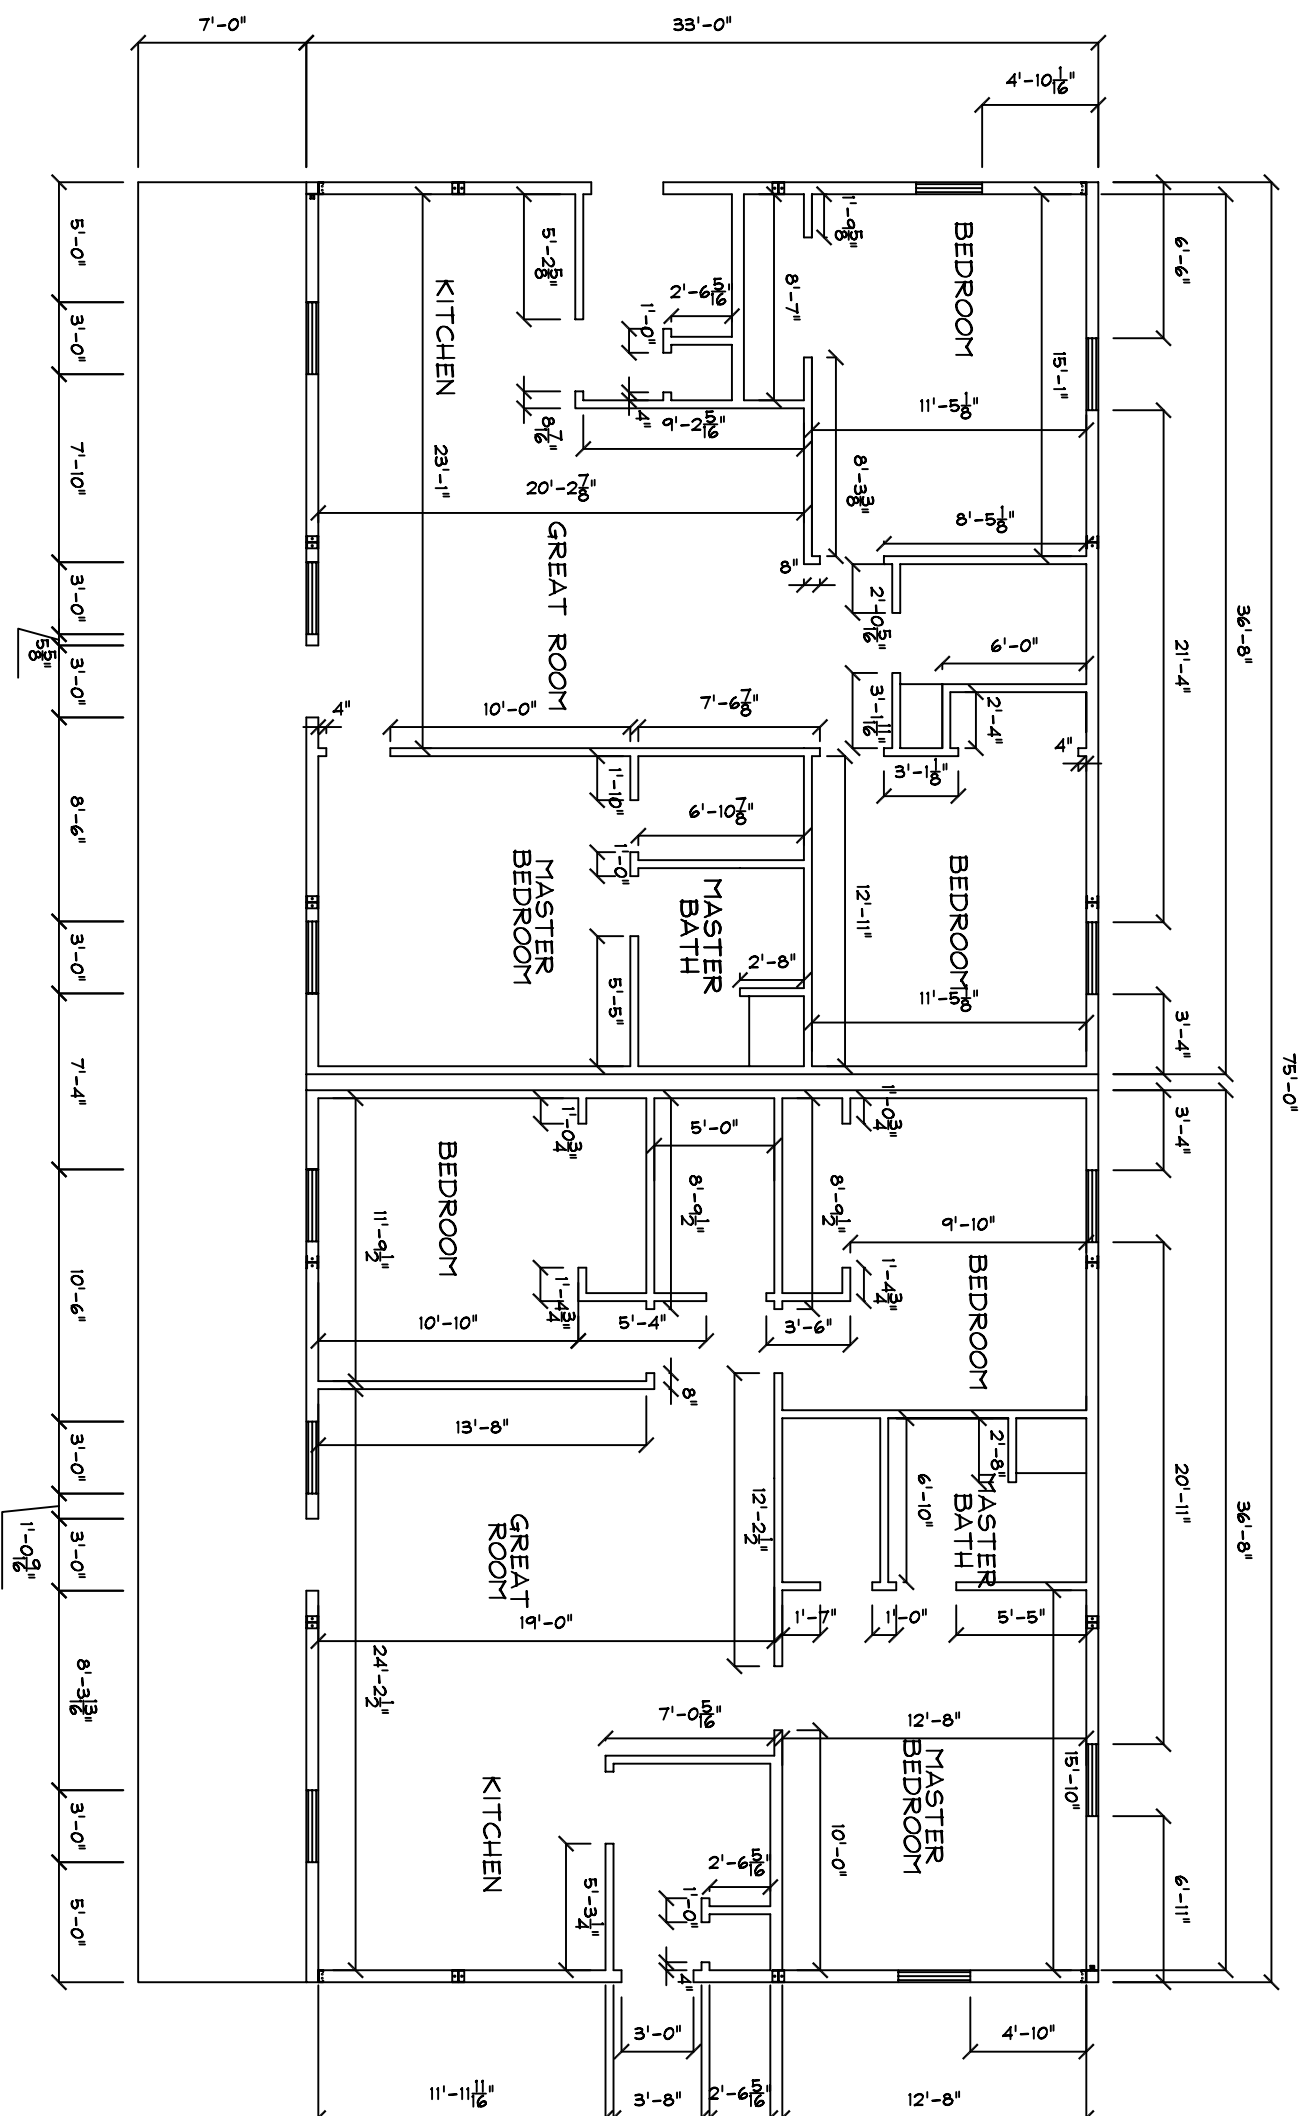

DIMENSION
LAYOUT

DRAWING NO
A3

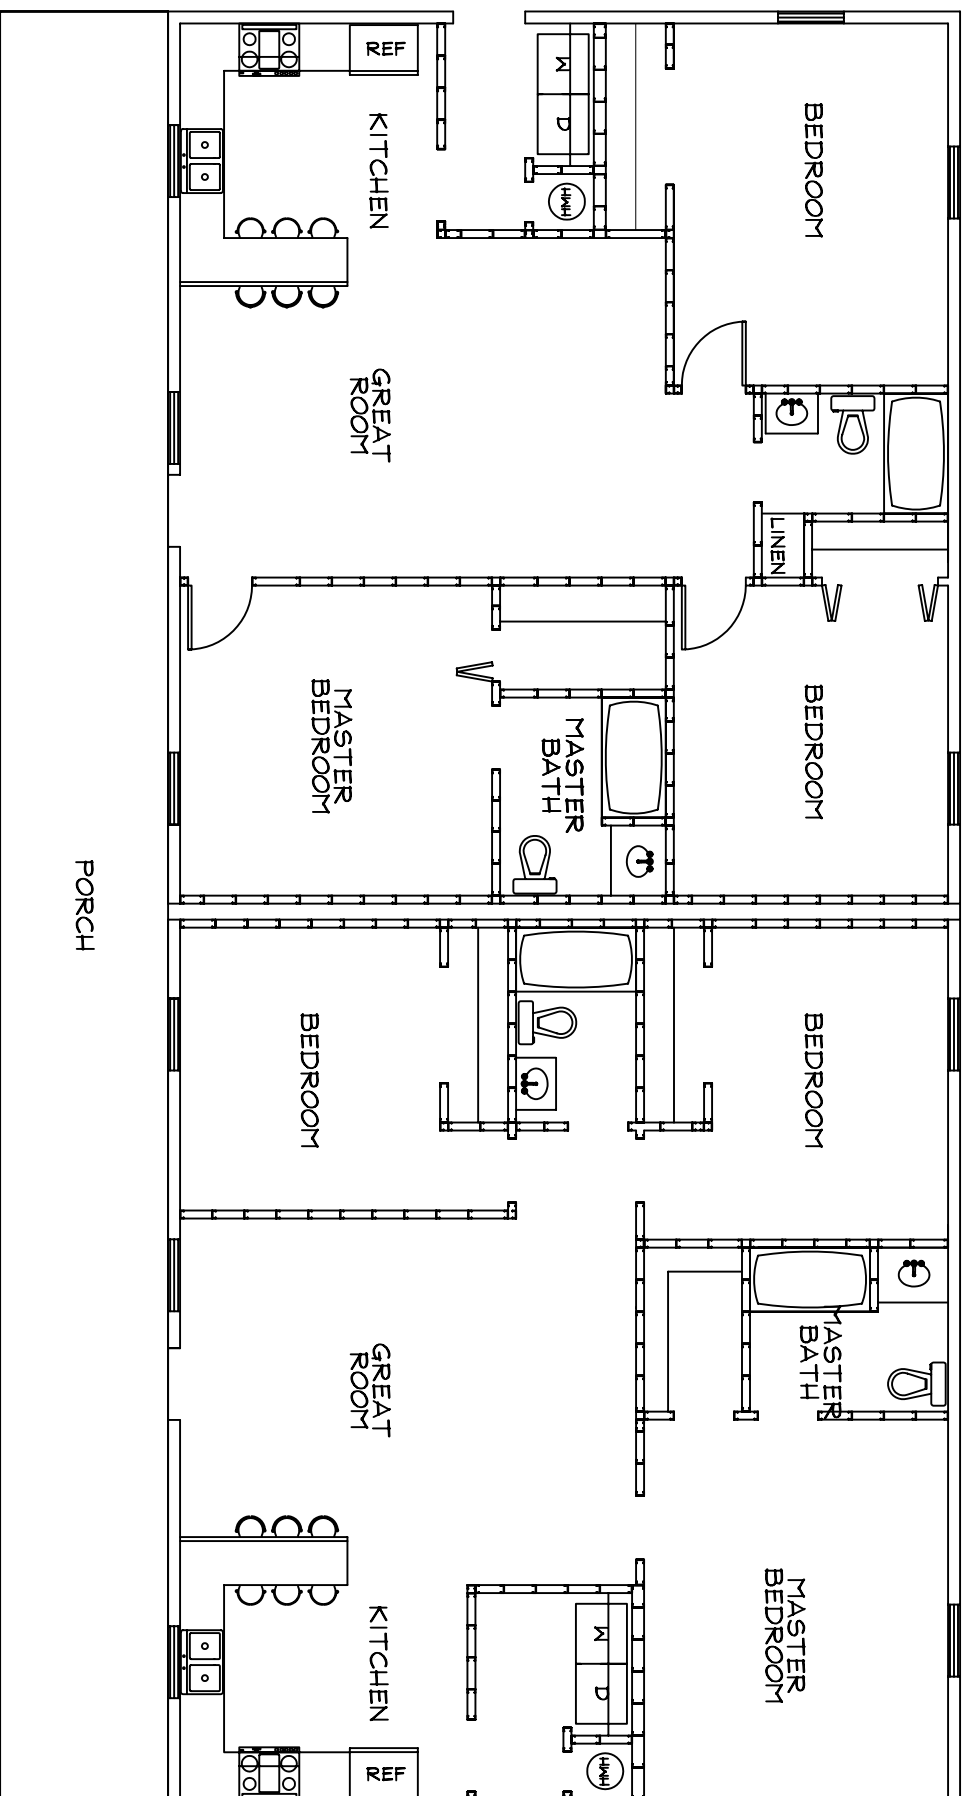


Kodiak Steel Homes, Inc
 7301 Industry Drive
 North Little Rock, AR 72117

DU-PLEX
 40' X 75'

INTERIOR
 STUD LAYOUT

DRAWING NO.

AA

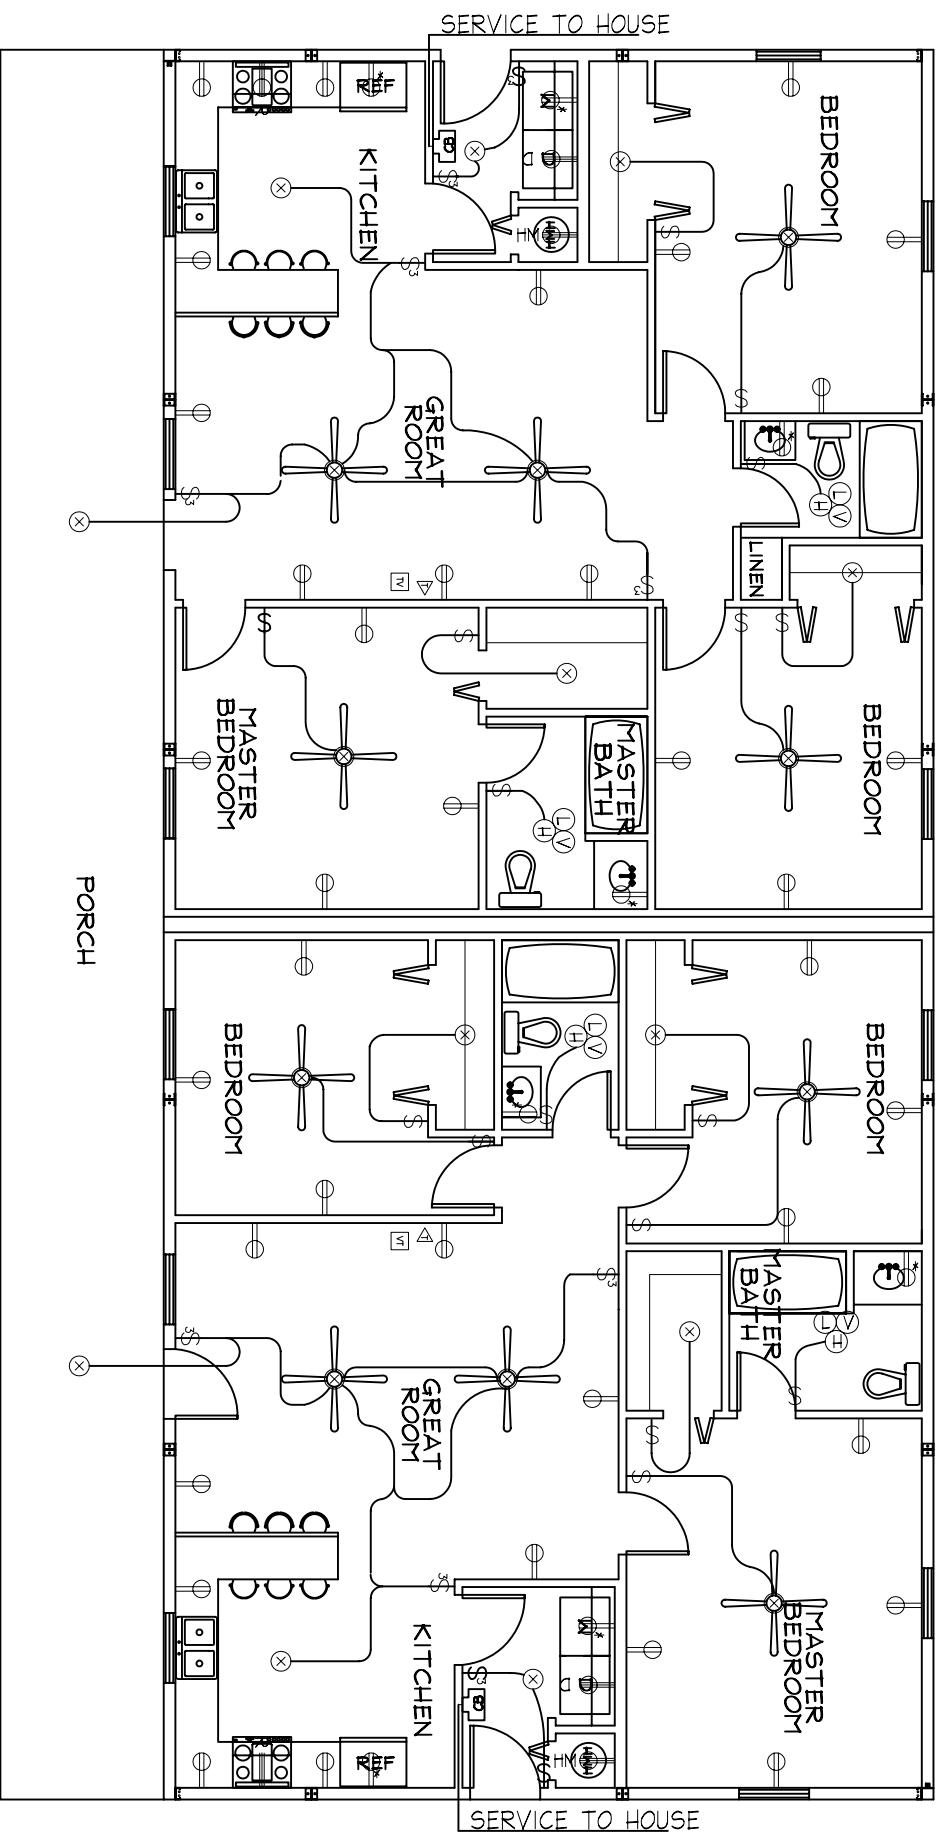

| ELECTRICAL SERVICE | | |
|--------------------|----------------------------------|-------|
| LEGEND | DESCRIPTION | NOTES |
| CB | CIRCUIT BREAKER PANEL | |
| SD | WIRELESS SMOKE DETECTOR | |
| SW | STANDARD WALL SWITCH | |
| 3W | STANDARD 3 WAY WALL SWITCH | |
| DU | STANDARD DUPLEX WALL OUTLET | |
| SM | SPLIT WIRED DUPLEX WALL OUTLET | |
| 220 | STANDARD 220 VOLT WALL OUTLET | |
| GF | GROUND FAULT CIRCUIT INTERRUPTER | |
| MC | MOTOR CIRCUIT | |
| WH | WATER HEATER (220 VOLT) | |
| LV | LIGHT - VENT HEATER | |
| WP | WEATHER PROOF DUPLEX OUTLET | |
| RO | RANGE / OVEN (220 VOLT) | |
| CD | CLOTHES DRYER (220 VOLT) | |
| CL | CEILING MOUNTED LIGHT | |
| XL | WALL MOUNTED EXTERIOR LIGHT | |
| DM | DISH WASHER | |
| GD | GARBAGE DISPOSAL | |
| TC | TRASH COMPACTOR | |
| TJ | TELEPHONE JACK | |
| TO | TELEVISION OUTLET | |
| DC | DOOR CHIME | |
| DT | DOOR CHIME TRANSISTOR | |



Kodiak Steel Homes, Inc
 7301 Industry Drive
 North Little Rock, AR 72117

DU-PLEX
 40' X 75'

ELECTRICAL

DRAWING NO.

A5